



ELECTRICAL LAYOUT FOR FLAT NO. 101.

ROOM	CONTROLLED BY	DESCRIPTIONS	MODULAR	HEIGHTS	NOTE	ROOM	CONTROLLED BY	DESCRIPTIONS	MODULAR	HEIGHTS	NOTE	ROOM	CONTROLLED BY	DESCRIPTIONS	MODULAR	HEIGHTS	NOTE
LOBBY	S/W 01	1 CEILING FT. (E.W.) 1 BELL CORNER	2M	1100	TWO WAY	KITCHEN	S/W 13	2 NOS. CEILING LIGHTS 1 NOS. BRACKET LIGHT 1 EXHAUST FAN 1 CEILING FAN 1 AQUAGUARD SWITCH PT.	8M	1100		BED ROOM - 3	S/W 23	1 BRACKET LIGHT (E.W.) 1 BRACKET LIGHT 1 CEILING FAN	4M	1100	TWO WAY
LIVING RM	S/W 02	1 CEILING FT. 1 BRACKET LIGHT	4M	1100	TWO WAY		S/W 14	4AMP. SOCKET PT. FOR AQUAGUARD	2M	2240			S/W 24	1 NOS. 6 AMP. OUTLET	3M	300	
	S/W 03	4 AMP. OUTLET	3M	300			S/W 15	1 NOS. 6 AMP. OUTLET	4M	1100			S/W 25	AC POINT	2M	2240	
	S/W 04	TV. OUTLET	2M	300			S/W 16	1 NOS. 6 AMP. OUTLET	3M	2940			S/W 27	1 TV. OUTLET	2M	300	
	S/W 05	2 NOS. 6 AMP. OUTLET	2M	300			S/W 17	1 NOS. 16 AMP/8 PHN OUTLET	4M	300			S/W 28	6 AMP. OUTLET	3M	300	
	S/W 06	1 CEILING FT. 1 BRACKET LIGHT	6M	1100			S/W 18	1 NOS. 16 AMP/8 PHN OUTLET	4M	300			S/W 29	1 EXHAUST FAN 1 CEILING FT. (E.W.)	3M	1100	
DINING RM	S/W 07	AC POINT	2M	2240		BED ROOM BALCONY	S/W 20	1 NOS. 16 AMP/8 PHN OUTLET	4M	300		PASSAGE	S/W 31	1 CEILING FT. (E.W.)	2M	1100	TWO WAY
	S/W 08	4 AMP. OUTLET	3M	300			S/W 21	1 BRACKET LIGHT (E.W.) 1 FOOT LIGHT	2M	1100	TWO WAY		S/W 32	1 CEILING FT. (E.W.)	2M	1100	TWO WAY
	S/W 09	1 BRACKET LIGHT (E.W.) 3 CEILING FT. 1 BRACKET LIGHT 1 CEILING FAN	8M	1100		BED ROOM - 2	S/W 21A	1 NOS. 6 AMP. OUTLET	3M	300			S/W 33	1 TV. OUTLET	2M	300	
	S/W 10	4 AMP. OUTLET	3M	300			S/W 22	1 TELEPHONE OUTLET	3M	300			S/W 34	2 BRACKET LIGHT (E.W.) 1 BRACKET LIGHT 1 CEILING FAN	8M	1100	TWO WAY
LIVING BALCONY	S/W 12	4 AMP. OUTLET	3M	300		BED ROOM BALCONY	S/W 41	1 BRACKET LIGHT (E.W.)	2M	1100			S/W 35	1 NOS. 6 AMP. OUTLET	3M	300	
BED ROOM-1	S/W 33	1 CEILING FT. 1 BRACKET LIGHT (E.W.) 1 FOOT LIGHT	3M	1100			S/W 41A	1 NOS. 6 AMP. OUTLET	3M	300			S/W 36	AC POINT	2M	2240	
	S/W 34	2 BRACKET LIGHT (E.W.) 3 BRACKET LIGHT 1 CEILING FAN	8M	1100	TWO WAY		S/W 42	2 BRACKET LIGHT 1 NOS. 6 AMP. OUTLET 1 EXHAUST FAN 1 GEYSER FT.	8M	1100			S/W 37	1 NOS. 6 AMP. OUTLET	3M	300	
	S/W 34A	1 NOS. 6 AMP. OUTLET 1 FOOT LIGHT FITTING	3M	300			S/W 42A	1 GEYSER SOCKET PT.	3M	2400			S/W 38	1 NOS. 6 AMP. OUTLET	3M	300	
	S/W 35	TELEPHONE OUTLET	2M	300			S/W 43	1 BRACKET LIGHT (E.W.) 1 FOOT POINT	2M	1100			S/W 39	TV. OUTLET	2M	300	
	S/W 36	AC POINT	2M	2240			S/W 43A	1 NOS. 6 AMP. OUTLET 1 FOOT LIGHT FITTING	3M	300			S/W 40	1 NOS. 6 AMP. OUTLET	3M	300	
	S/W 37	1 NOS. 6 AMP. OUTLET	3M	300			S/W 44	1 CEILING FAN 1 BRACKET LIGHT (E.W.) 1 BRACKET LIGHT	6M	1100							
	S/W 38	1 NOS. 6 AMP. OUTLET	3M	300			S/W 44A	1 NOS. 6 AMP. OUTLET	3M	300							
	S/W 39	TV. OUTLET	2M	300			S/W 45	TELEPHONE OUTLET	2M	300							
	S/W 40	1 NOS. 6 AMP. OUTLET	3M	300			S/W 46	1 NOS. 6 AMP. OUTLET	3M	300							

LEGEND FOR ELECTRICAL

S/W	DESCRIPTION	SYMBOL
1	1.5 W WATT FLOURESCENT FITTURE ON CEILING	⊕
2	CEILING LIGHT	⊕
3	CHANDLER LIGHT ON CEILING	⊕
4	BRACKET LIGHT	⊕
5	CEILING FAN	⊕
6	EXHAUST FAN	⊕
7	CEILING ROSE	⊕
8	DISTRIBUTION BOARD	⊕
9	VIDEO DOOR PHONE	⊕
10	BELL POINT	⊕
11	FOOT LIGHT	⊕
12	SMOKE DETECTOR ON CEILING	⊕
13	HEAT DETECTOR ON CEILING	⊕
14	RESPONSE INDICATOR	⊕
15	HOME GATEWAY	⊕
16	SWITCH	⊕
17	TRIP SWITCH	⊕
18	SWITCH BOARD	⊕
19	MODULE	⊕
20	MODULE	⊕
21	MODULE	⊕
22	MODULE	⊕

ELECTRICAL LAYOUT FOR FLAT NO. 101,

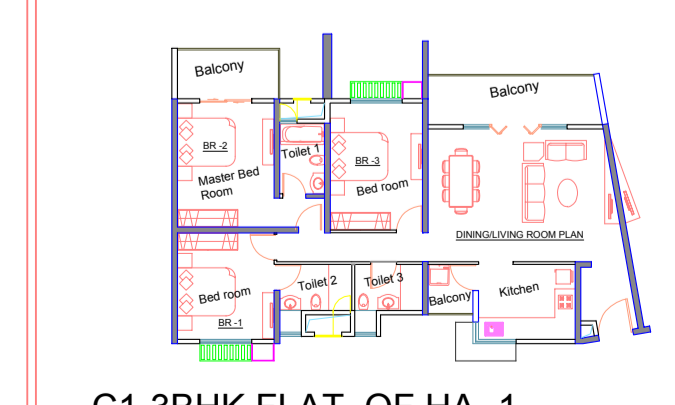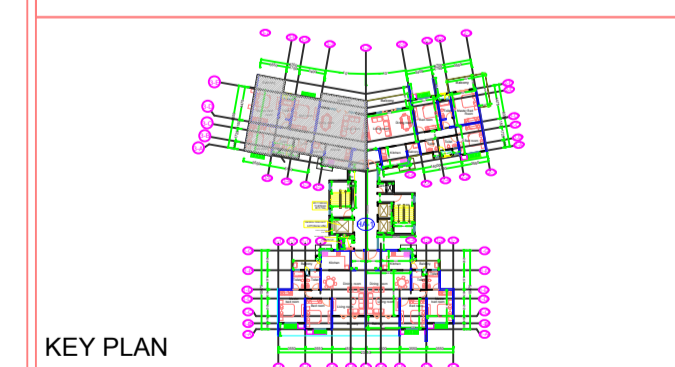

NOTES & REFERENCES

GENERAL NOTES -

- ALL DIMENSIONS ARE IN MILLIMETERS.
 - DIMENSIONS ARE TO BE READ AND NOT TO BE SCALED.
 - THE CONTRACTORS MUST VERIFY ALL DIMENSIONS ON SITE AND REFER THE RELEVANT STRUCTURAL AND OTHER CONSULTANT'S DRAWINGS BEFORE COMMENCING ANY WORK OR PREPARING ANY SHOP DRAWING, IN CASE ANY DISCREPANCY IS NOTICED THE SAME SHALL BE BROUGHT TO THE NOTICE OF THE ARCHITECT AND SHALL BE CLARIFIED BEFORE EXECUTION OF WORK.
 - REFER THIS DRAWING ALONG WITH THE OTHER RELEVANT ARCHITECTURAL, STRUCTURAL AND THE OTHER SERVICES DRAWINGS BEFORE THE EXECUTION OF WORK RELATED TO THIS DRAWING AT SITE.
- # THIS DRAWING @ FAIRWOOD CONSULTANTS PVT. LTD.

Status

GOOD FOR CONSTRUCTION

Rev. No.	Date	Description	By	Appd

PROJECT	BLUE RIDGE, HINJEWADI, PUNE
CLIENT	FLAGSHIP INFRASTRUCTURE PVT. LTD. HINJEWADI, PUNE
ARCHITECTS / CONSULTANTS	ECADI, Shanghai, China FAIRWOOD CONSULTANTS, India
STRUCTURAL CONSULTANTS	Y.S.SANE ASSOCIATES PUNE
PROJECT MANAGEMENT CONSULTANTS	ADVENT PROJECTS PUNE
BUILDING TYPE	HIGHRISE APARTMENT C-TYPE HA-1
DRAWING TITLE	SWITCH BOARD CONTROLLING LAYOUT PLAN OF C1-3BHK FLAT
Dwg. No.	FCLBR/Res/HA-1C1-3-BHK Controlling layout
Date	20-05-08
Design by	Scale NOT TO SCALE
Drawn by	Approved by SHRIDUDKAR